


Amendments		
Code	Date	Amendment

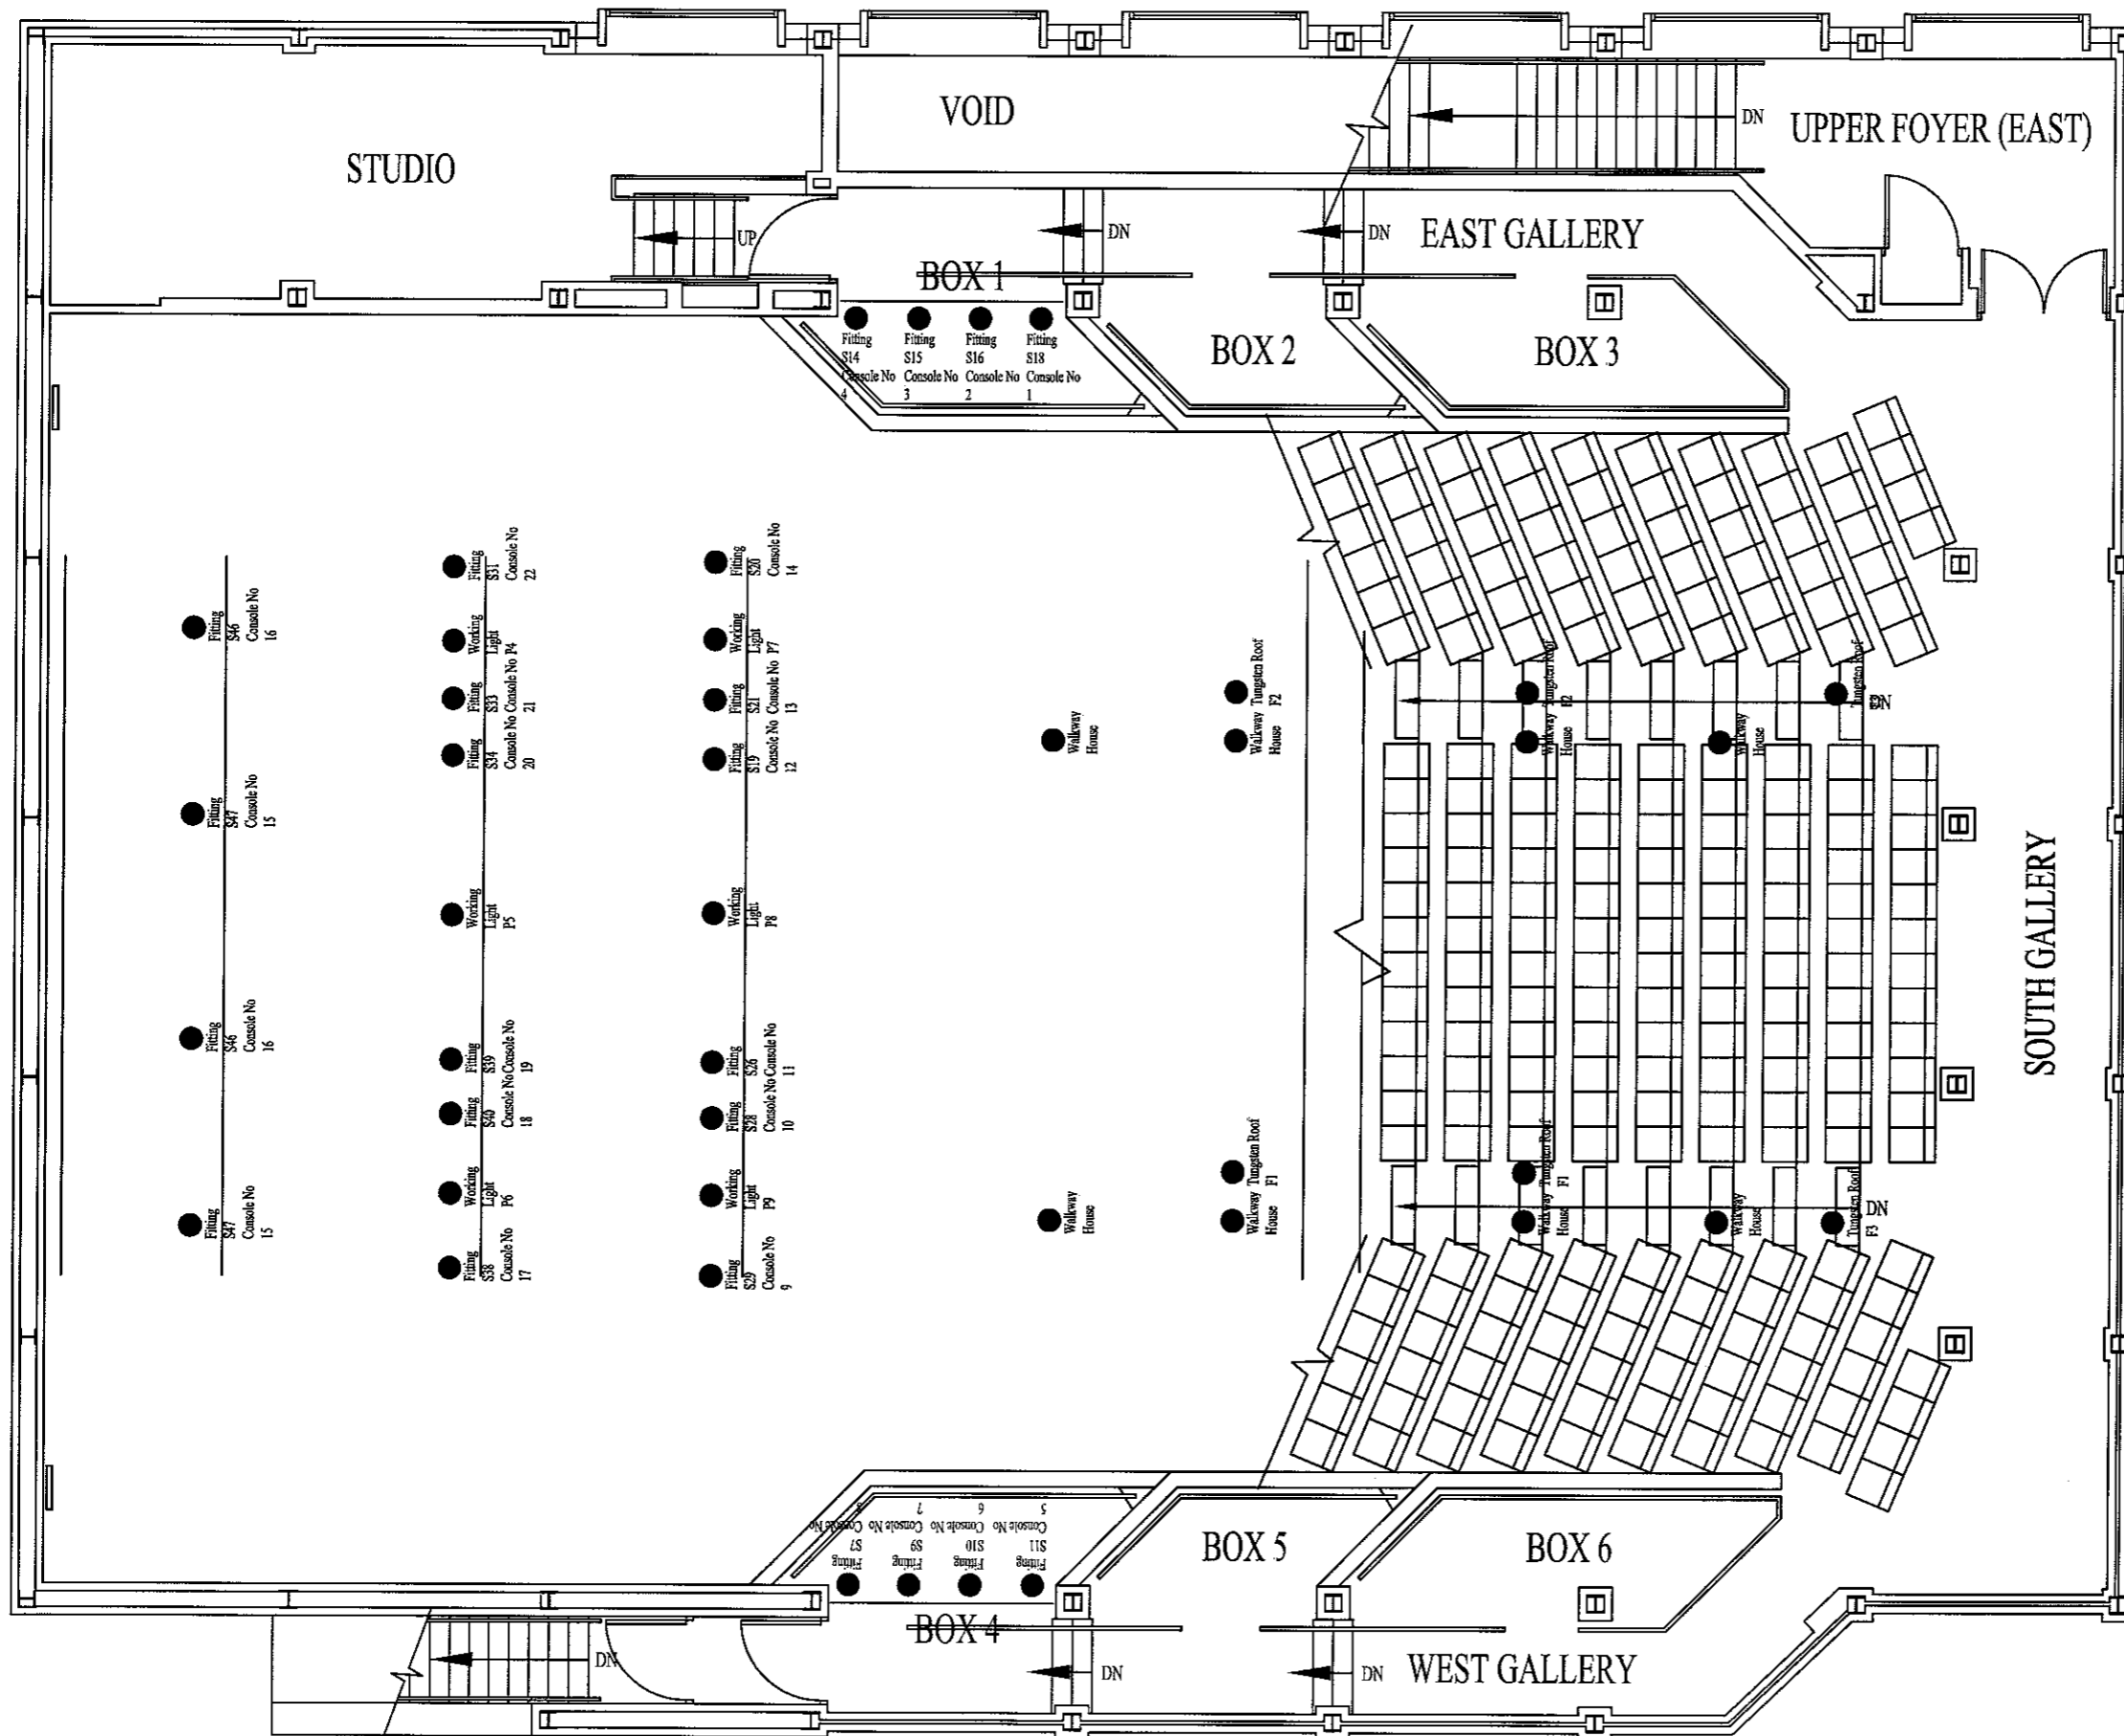

Notes

Do not scale this drawing. Take check dimensions on site. The contractor is responsible for pointing out all discrepancies to the Architect / Engineer. This drawing is copyright © University of Cambridge.



Estate Management and Building Service
74 Trumpington Street, Cambridge CB2 1RQ. Tel: 01223 337770

Project Title
Faculty of Music
Concert Hall

Sheet Title
Electrical Survey- Lighting Layout

Scale	Date	Drawn	Officer	Checked
DNS	Nov 02	PDF	JP	
Building Code	Project No.	Drawing No.	Revision	
S21C		S21C/02/01/E/1		

Stage lighting Standard Layout